




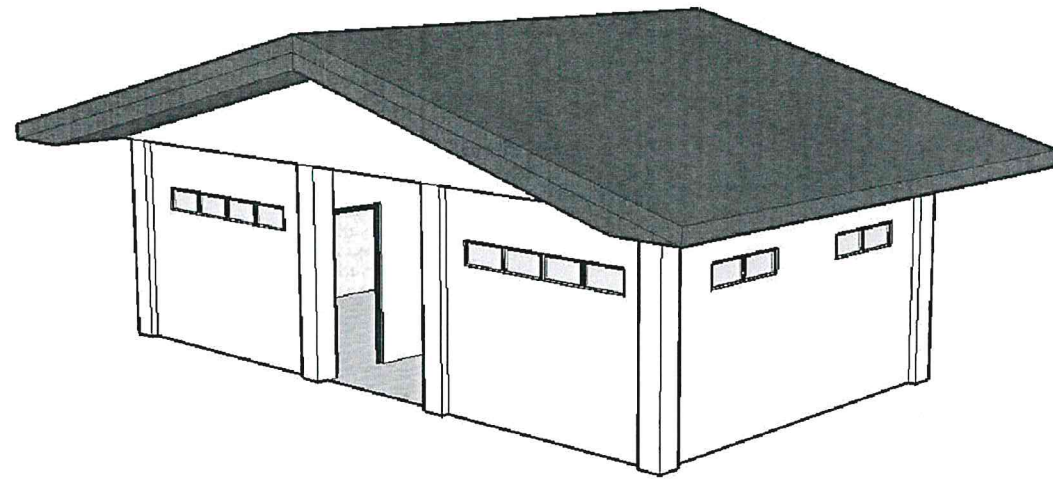


01 PERSPECTIVE
AR1 SCALE NTS

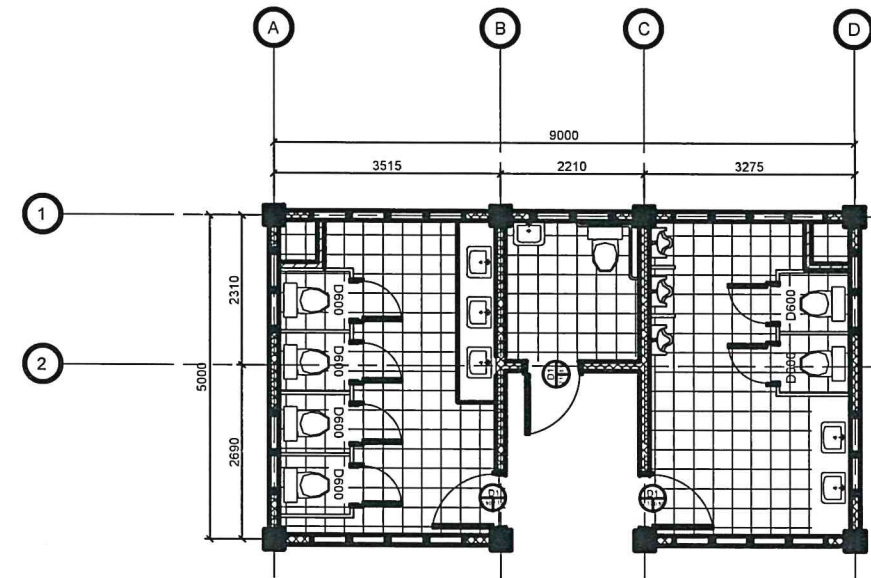

01 FLOOR PLAN LAYOUT
AR1 SCALE 1:100 MTS.

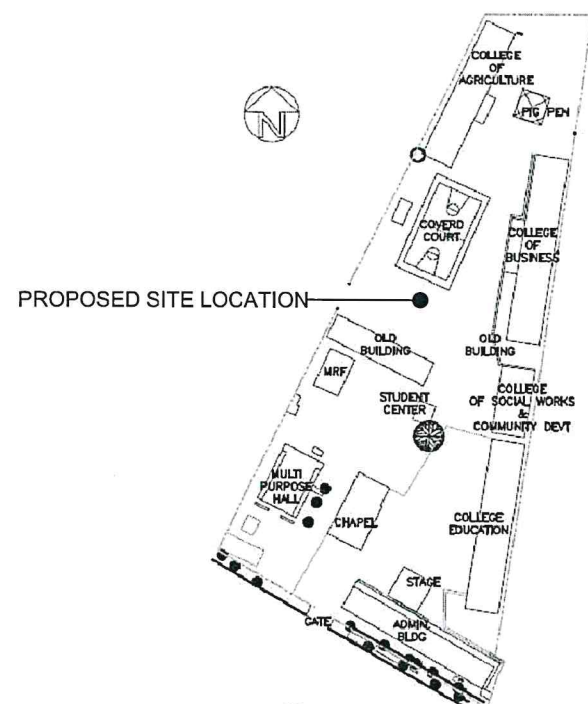


02 LOCATION PLAN
AR1 SCALE NTS

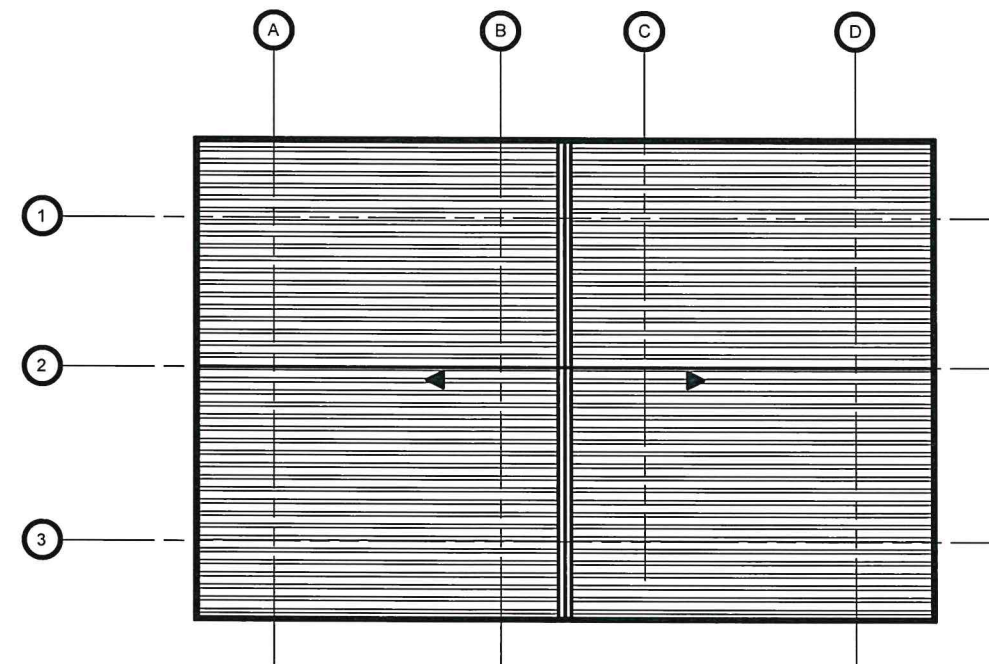


02 ROOF PLAN
AR1 SCALE 1:100 MTS.

PROJECT TITLE:	PREPARED AND DRAWN BY:	NOTED BY:	SUBMITTED BY:	RECOMMENDING APPROVAL:	APPROVED BY:	SHEET NO.:
 UNIVERSITY OF RIZAL SYSTEM UNIVERSITY PHYSICAL FACILITIES DEVELOPMENT UNIT	UPFDU					AR 1.0
	CHECKED BY:					
	NEL JOSHUA B. DELA CRUZ, RCE ENGINEER, UPFDU	STEVE S.J. MILLARE, RENP HEAD, UPFDU	BENJIE G. INGO CHIEF ADMINISTRATIVE OFFICER	RENATO F. DE LEMON, Ph.D. VICE PRESIDENT FOR ADMINISTRATION AND FINANCE	NANCY T. PASCUAL, Ed. D., RGC PRESIDENT	

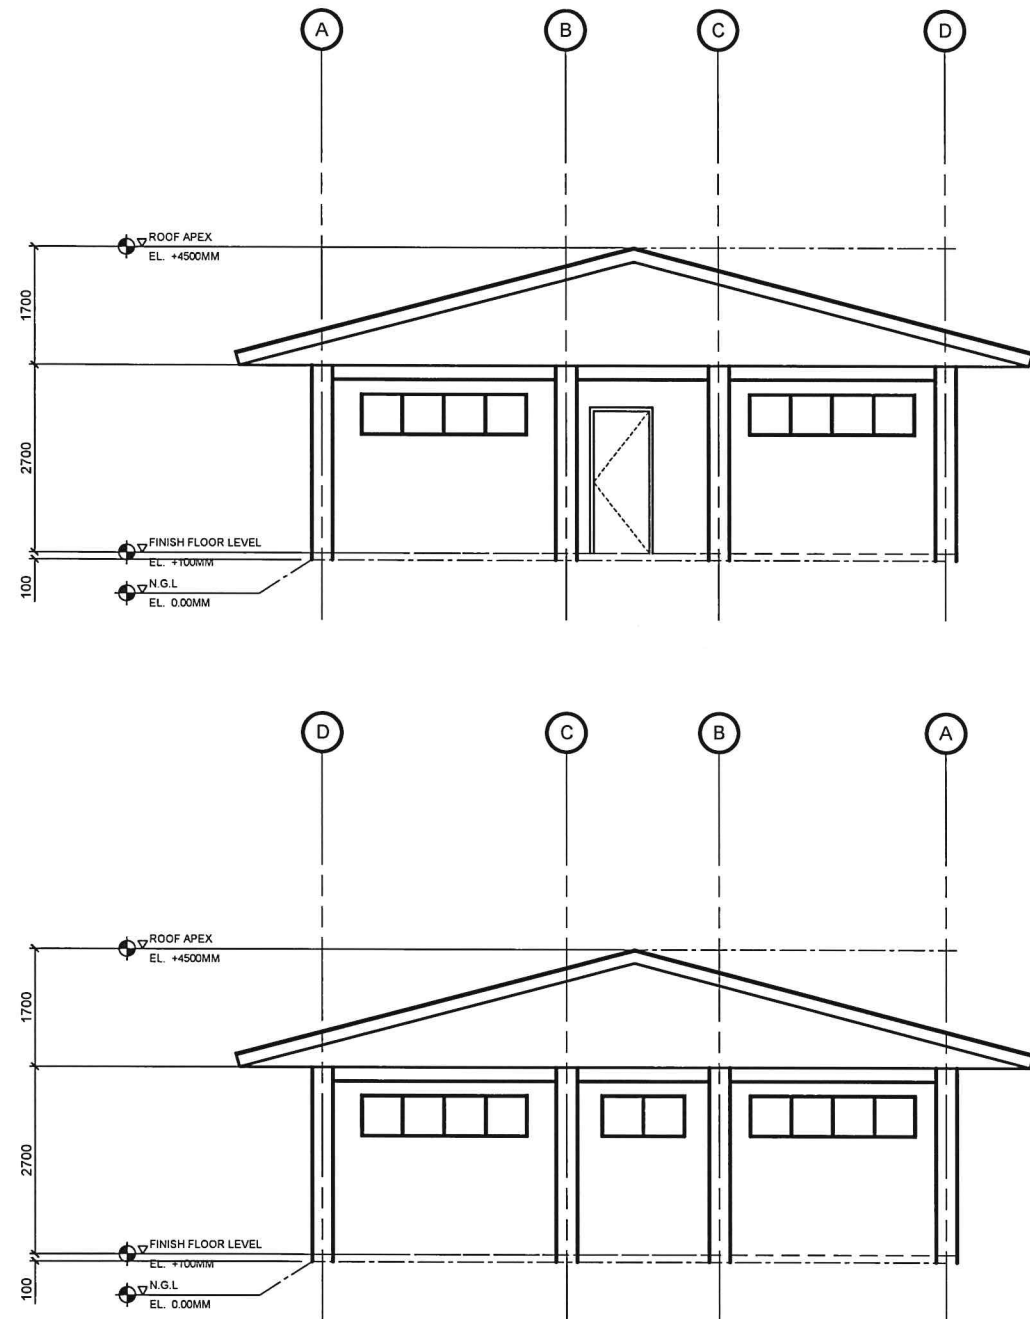

01 FRON & REAR ELEVATION
AR2 SCALE 1:100 MTS.

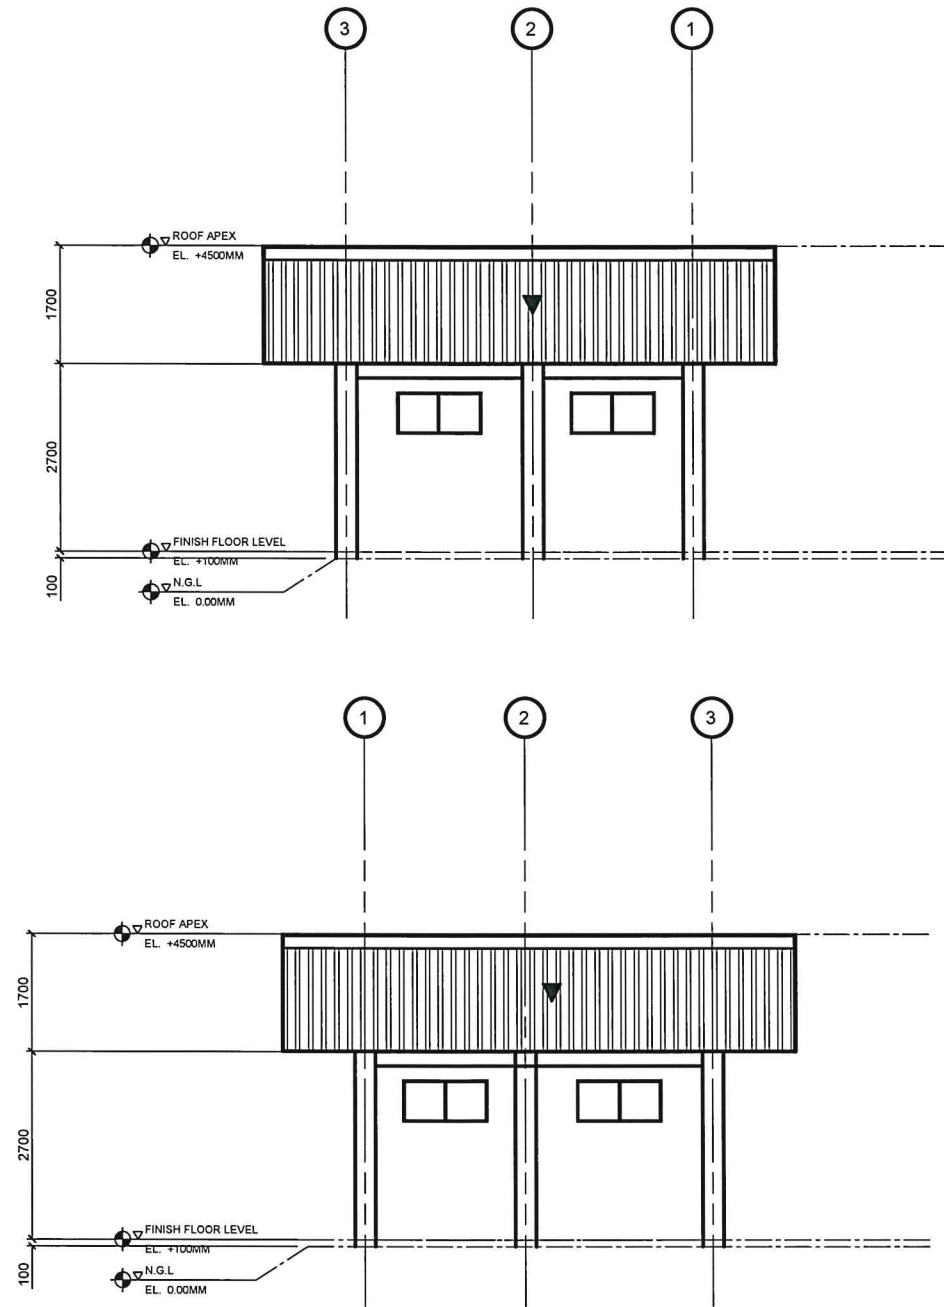

02 RIGHT & LEFT ELEVATION
AR2 SCALE 1:100 MTS.



UNIVERSITY OF RIZAL SYSTEM
UNIVERSITY PHYSICAL FACILITIES DEVELOPMENT UNIT

PROJECT TITLE:
**CAMPUS IMPROVEMENT FOR
STUDENT SERVICES
(REHABILITATION OF
COMFORT ROOMS AND
LAVATORY FACILITIES)**
RODRIGUEZ CAMPUS

PREPARED AND DRAWN BY:
UPFDU
CHECKED BY:
NEL JOSHUA P. DELA CRUZ, RCE
ENGINEER, UPFDU


NOTED BY:
STEVE S.J. MILLARE, RErP
HEAD, UPFDU

SUBMITTED BY:
BENJIE G. INGO
CHIEF ADMINISTRATIVE OFFICER


RECOMMENDING APPROVAL:
RENATO F. DE LEMON, Ph.D.
VICE PRESIDENT FOR
ADMINISTRATION AND FINANCE

APPROVED BY:
NANCY T. PASCUAL, Ed. D., RGC
PRESIDENT

SHEET NO.:
AR
2.0

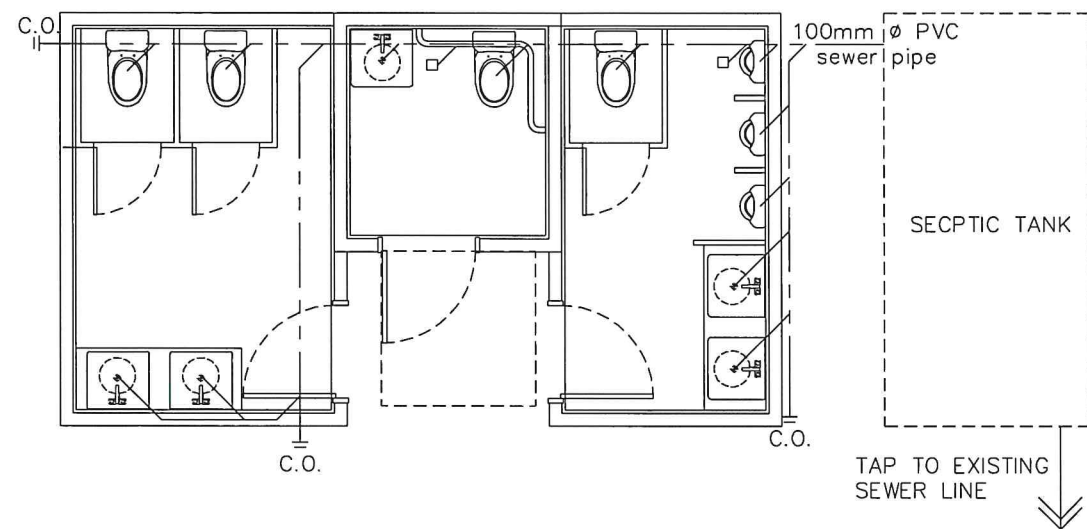


SANITARY LINE

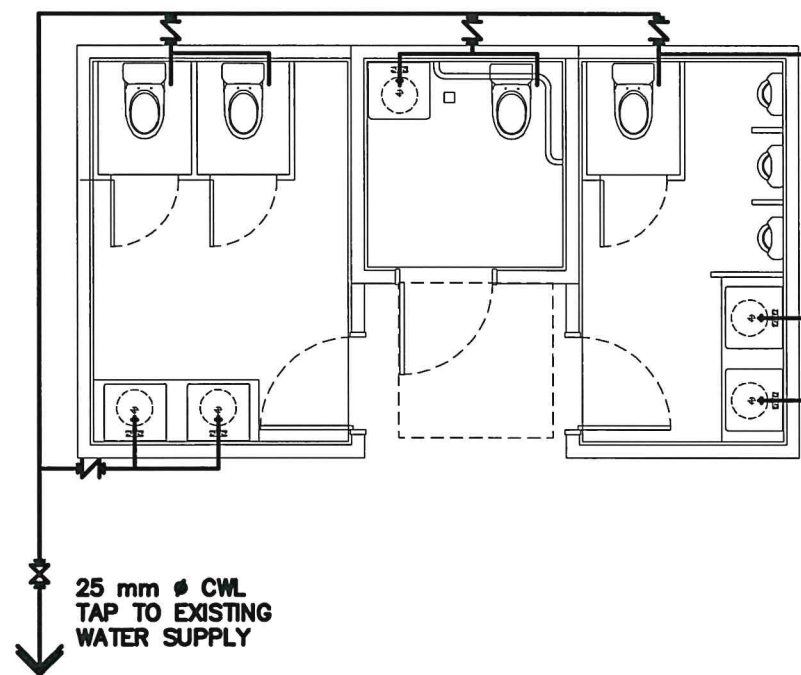


WATER LINE

1 PLUMBING LAYOUT
AR 1.0 AR 1.0
SCALE (20x30)
SCALE (A-3)
1:100
1:200

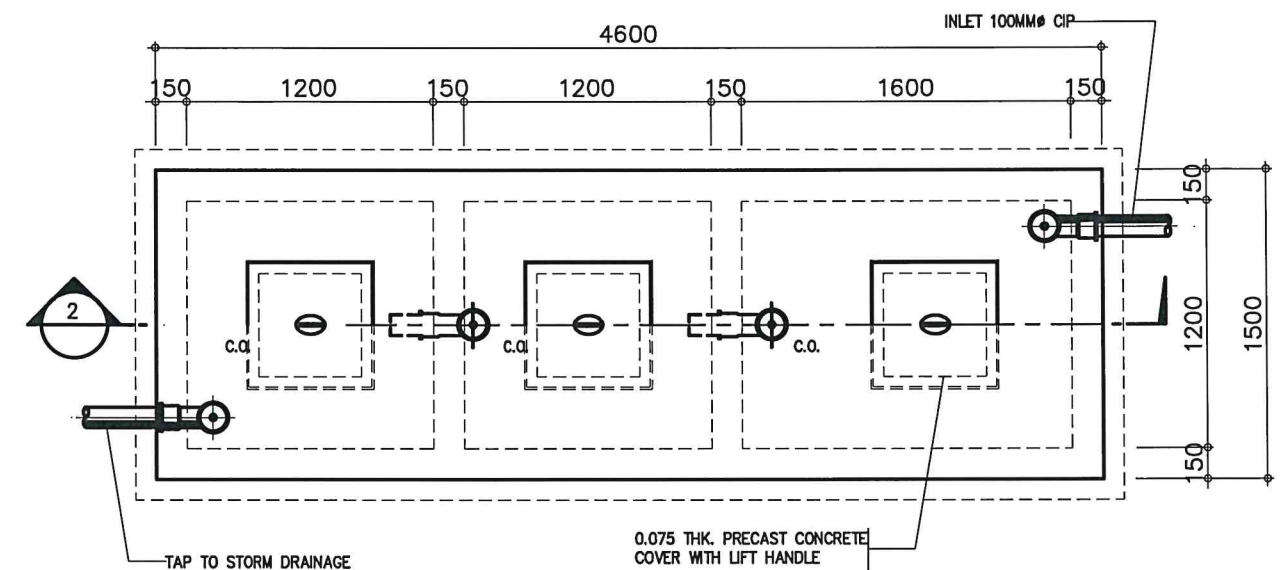

PLAN

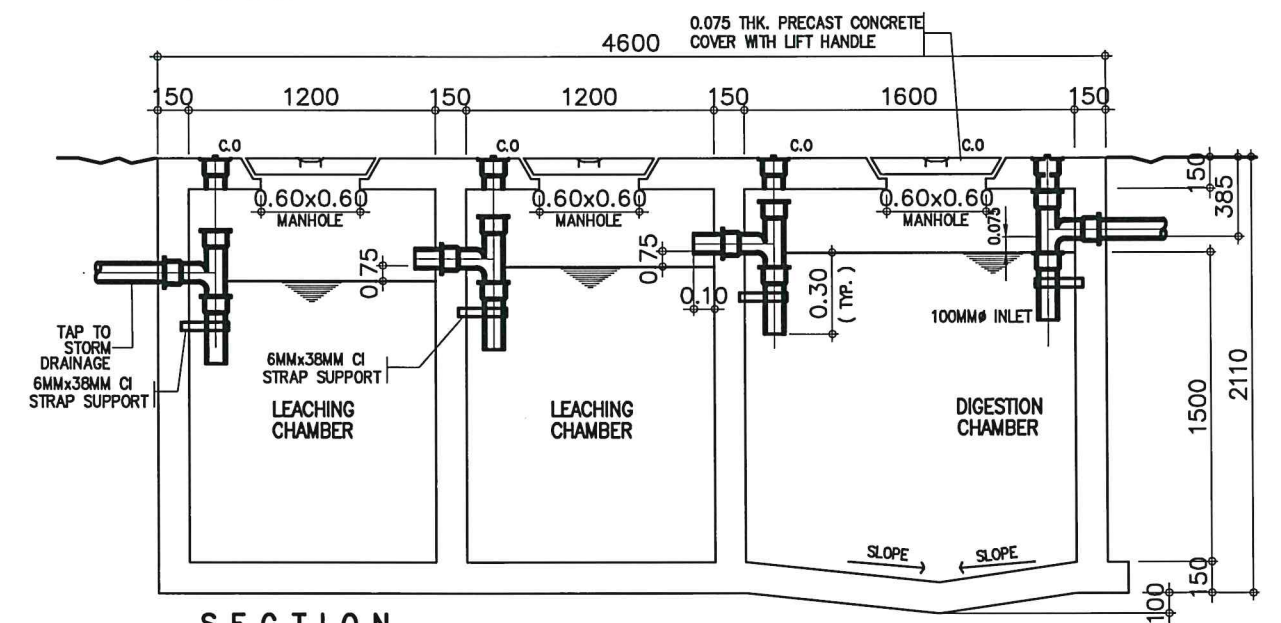

SECTION


02
P-1.0

SEPTIC TANK DETAIL


SCALE

NTS

 UNIVERSITY OF RIZAL SYSTEM UNIVERSITY PHYSICAL FACILITIES DEVELOPMENT UNIT	PROJECT TITLE: CAMPUS IMPROVEMENT FOR STUDENT SERVICES (REHABILITATION OF COMFORT ROOM AND LAVATORY FACILITIES) RODRIGUEZ CAMPUS	PREPARED AND DRAWN BY: UPFDU CHECKED BY: NEL JOSHUA P. DELA CRUZ, RCE ENGINEER, UPFDU	NOTED BY: STEVE S. MILLARE, REnP HEAD, UPFDU	SUBMITTED BY: BENJIE G. INGCO CHIEF ADMINISTRATIVE OFFICER	RECOMMENDING APPROVAL: RENATO F. DE LEMON, Ph.D. VICE PRESIDENT FOR ADMINISTRATION AND FINANCE	APPROVED BY: NANCY T. PASCUAL, Ed. D., RGC PRESIDENT	SHEET NO.: PL 1.0
--	--	---	---	---	---	---	-------------------------------------

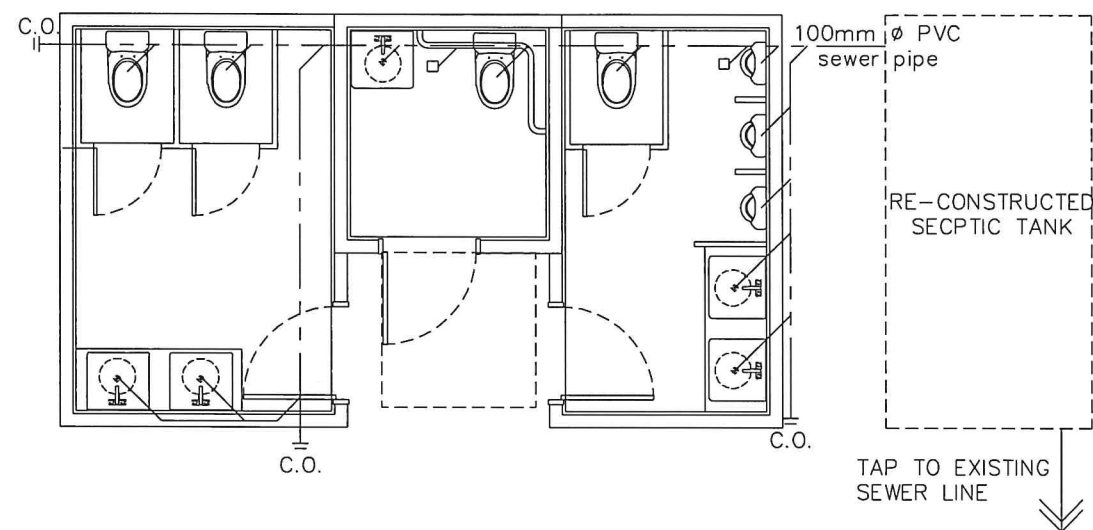


SANITARY LINE

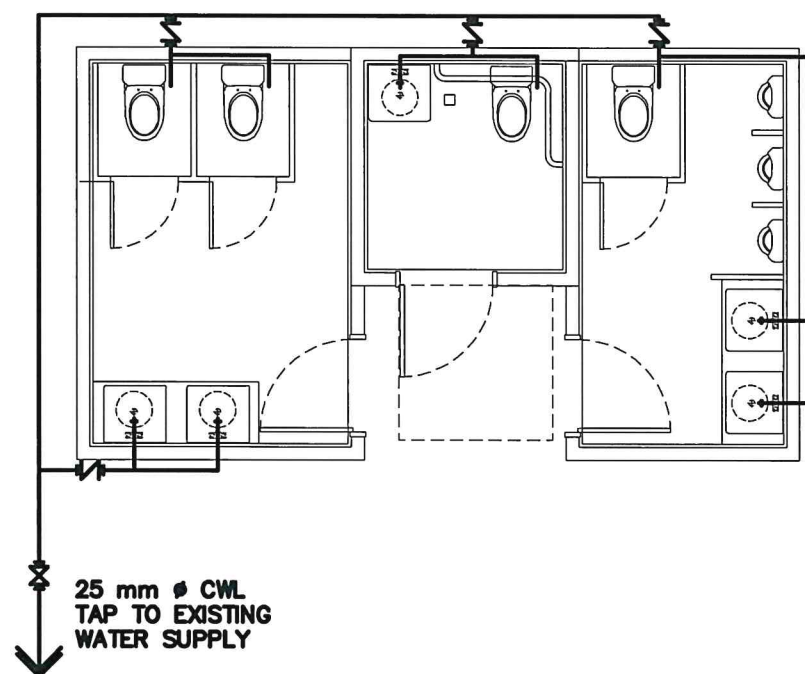


WATER LINE

01 PLUMBING LAYOUT
SCALE (20x30)
SCALE (A-3)
1:100
1:200

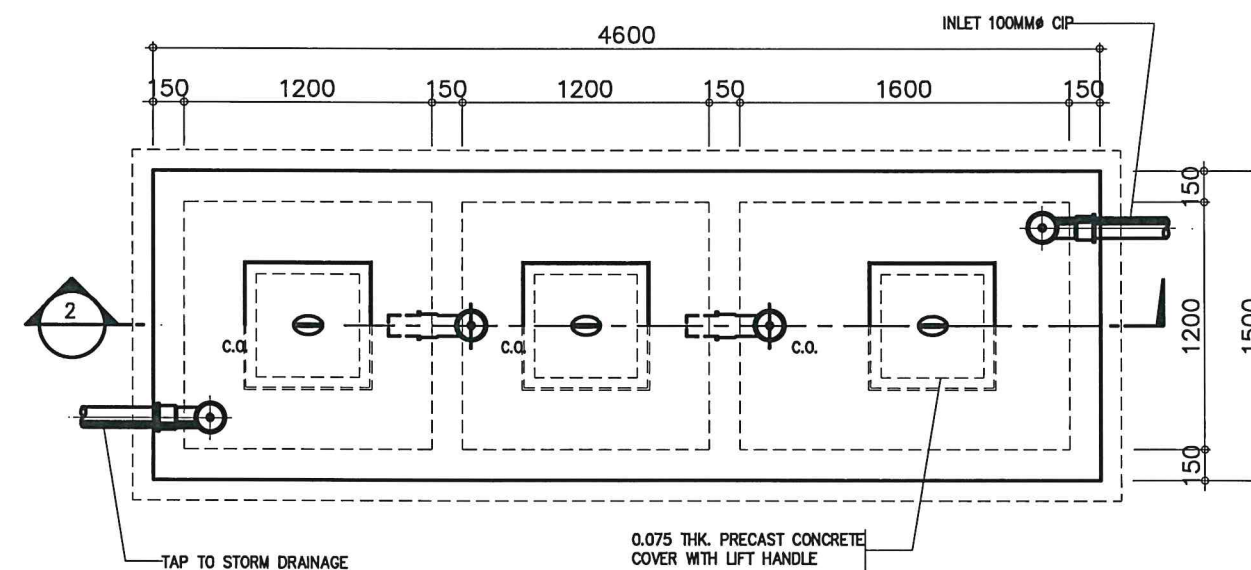

PLAN

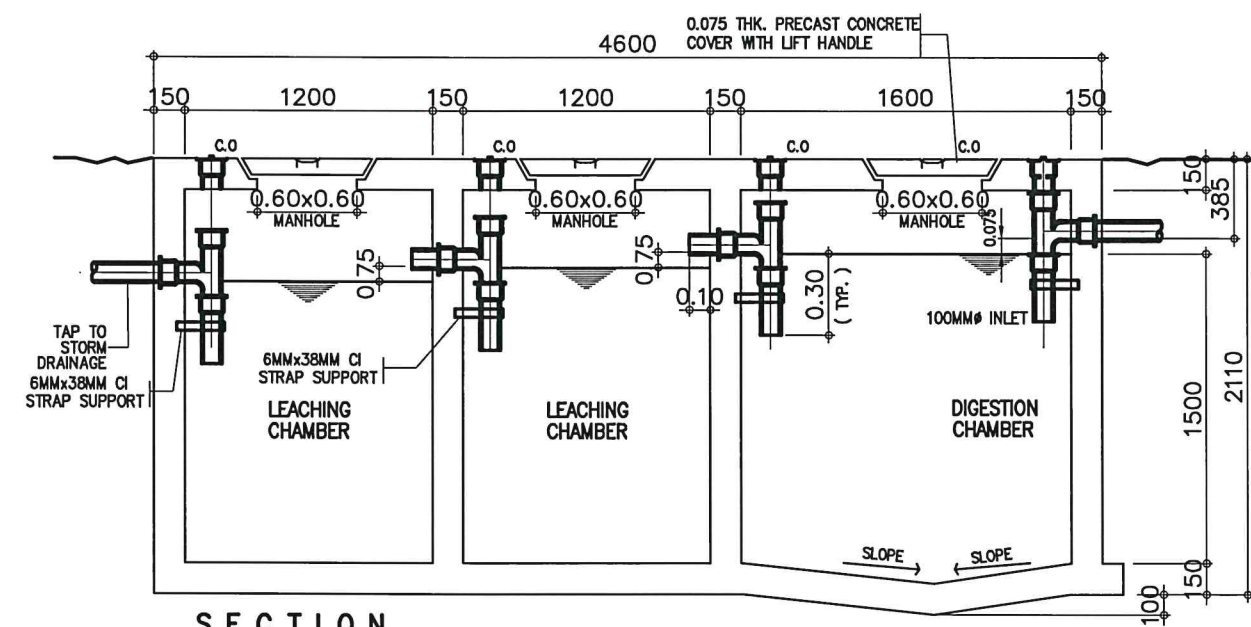

SECTION

02 SEPTIC TANK DETAIL
SCALE NTS

 UNIVERSITY OF RIZAL SYSTEM UNIVERSITY PHYSICAL FACILITIES DEVELOPMENT UNIT	PROJECT TITLE: CONSTRUCTION OF COMFORT ROOM AT UNIVERSITY OF RIZAL SYSTEM - RODRIGUEZ RODRIGUEZ CAMPUS	PREPARED AND DRAWN BY: UPFDU CHECKED BY: NEL JOSHUA P. DELA CRUZ, RCE ENGINEER, UPFDU	NOTED BY: STEVE S. MILLARE, REnc HEAD, UPFDU	SUBMITTED BY: BENJIE G. INGO CHIEF ADMINISTRATIVE OFFICER	RECOMMENDING APPROVAL: RENATO F. DE LEMON, Ph.d. VICE PRESIDENT FOR ADMINISTRATION AND FINANCE	APPROVED BY: NANCY T. PASCUAL, Ed. D., RGC PRESIDENT	SHEET NO.: PL 2.0
---	--	---	--	---	--	--	--